


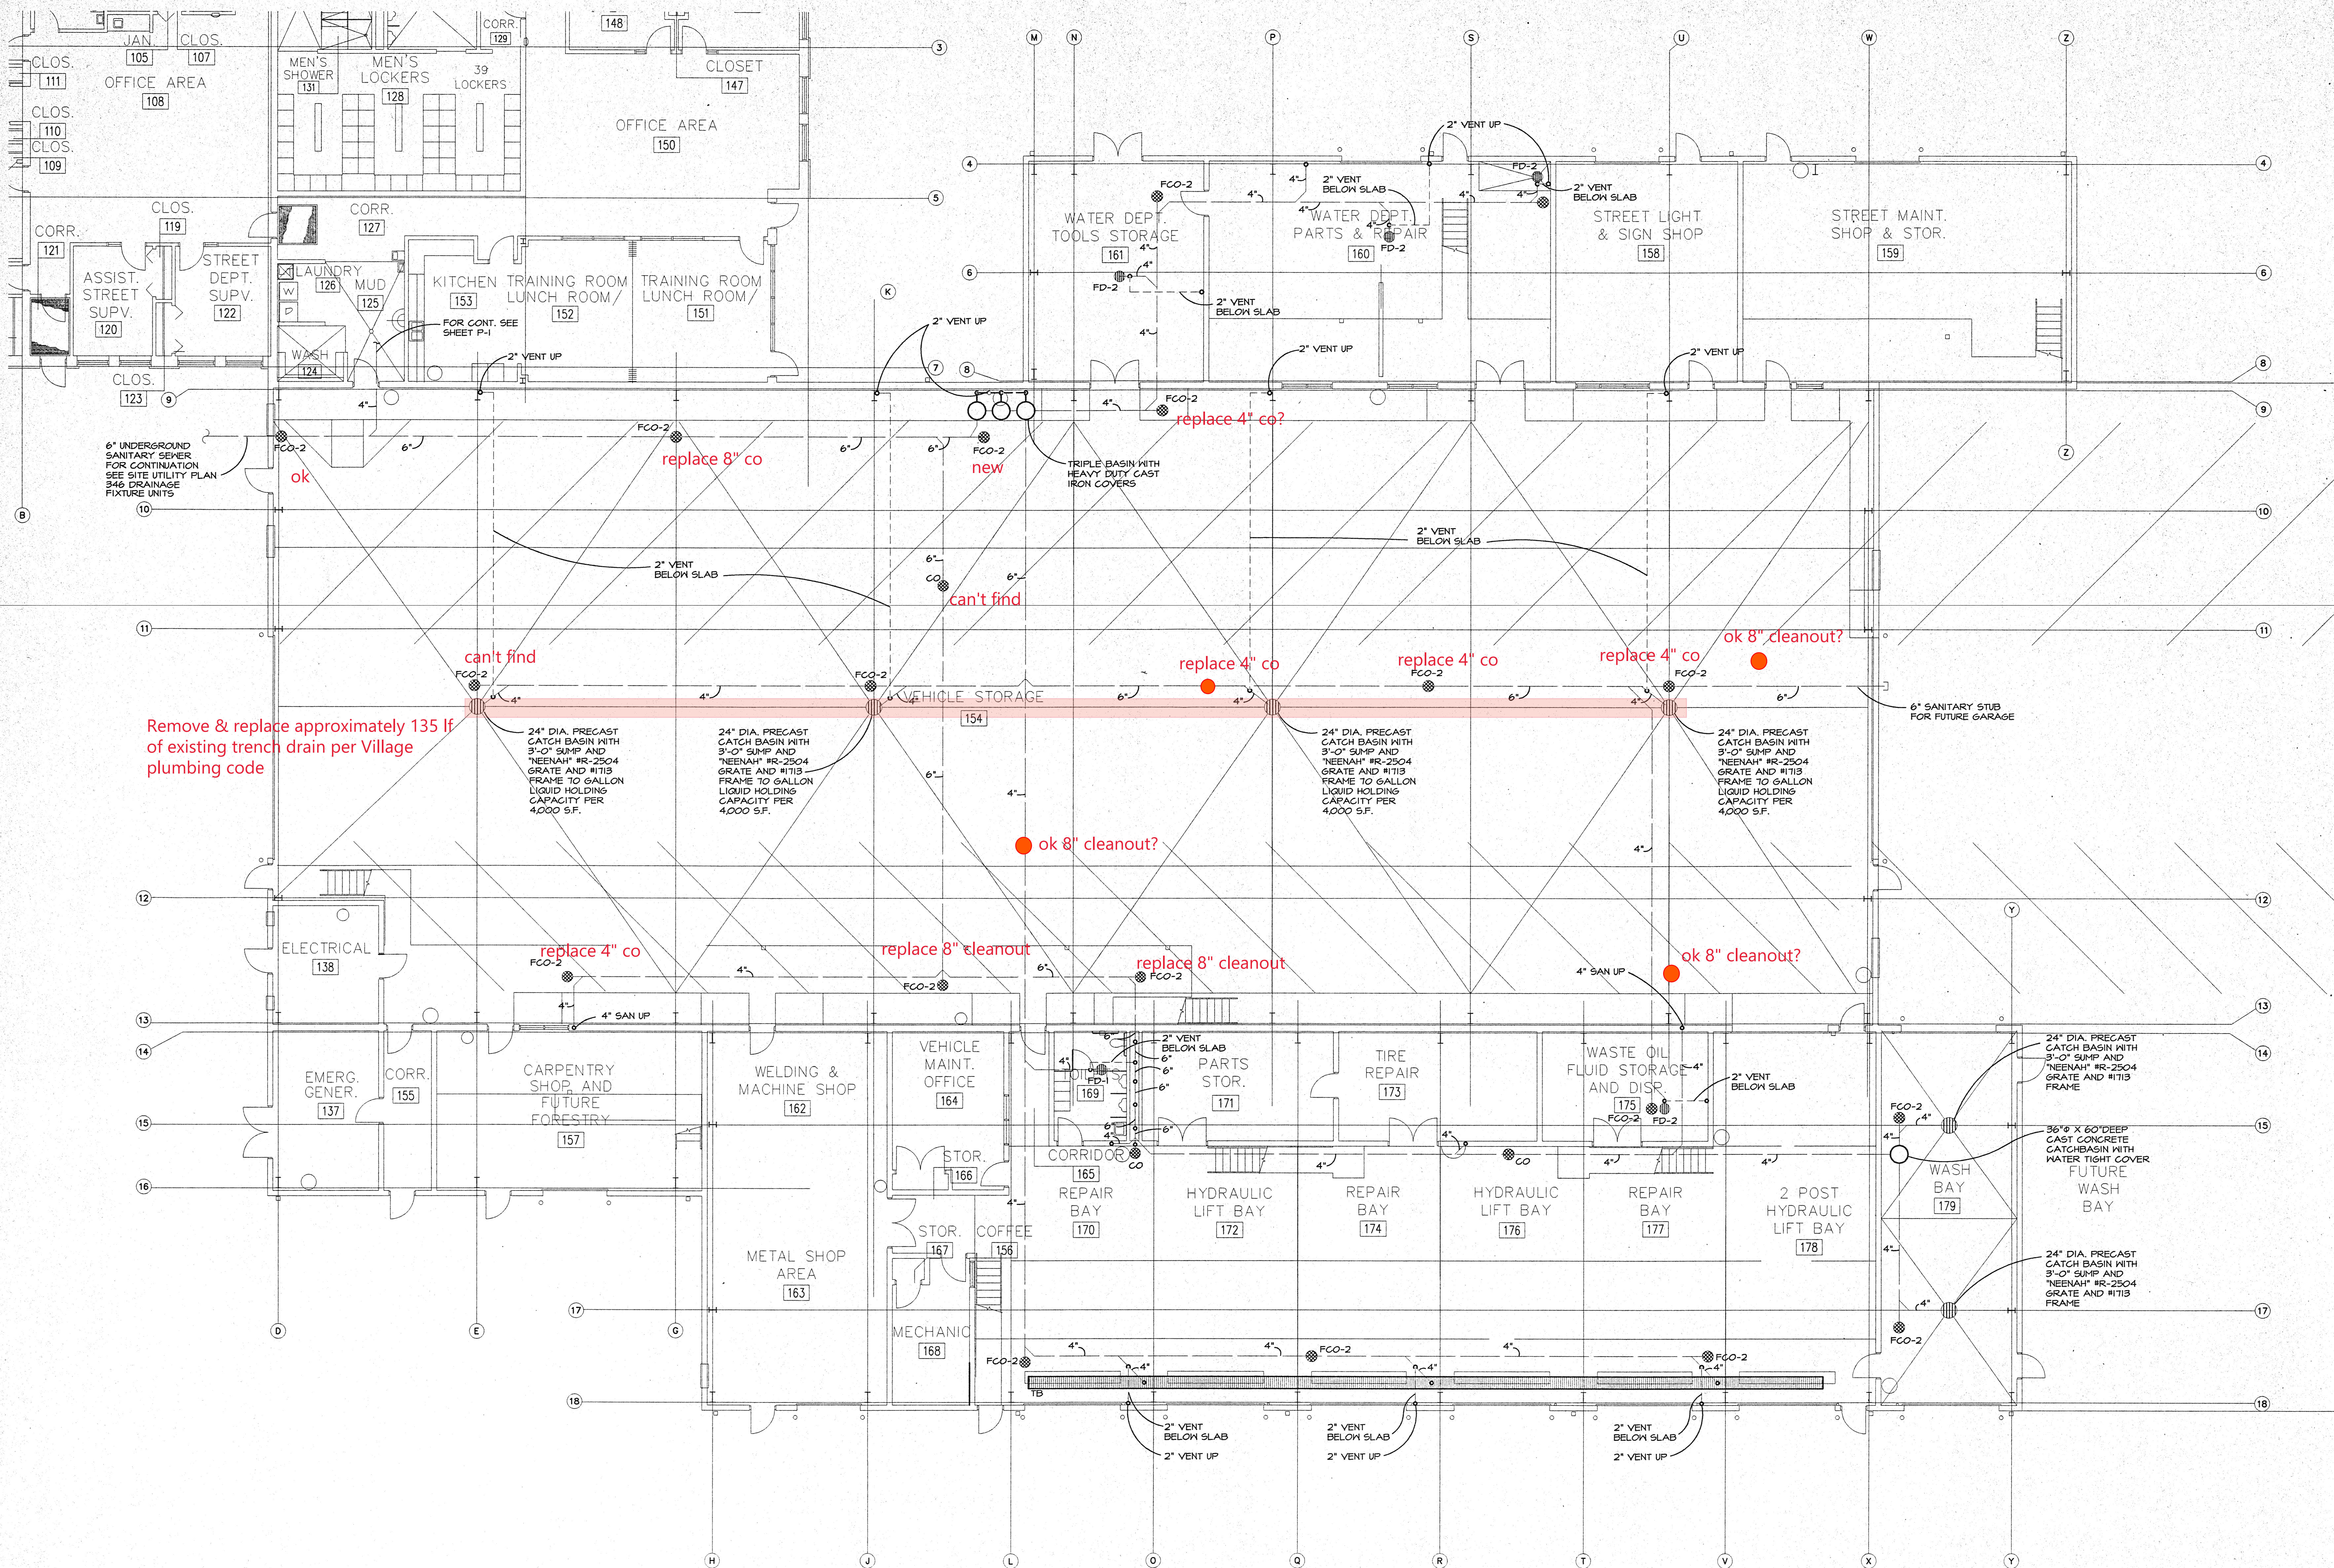

GARAGE PLUMBING PLAN

SCALE 1/8" = 1'-0"

REVISIONS

VILLAGE OF GURNEE PUBLIC WORKS
NEW FACILITY
ILLINOIS
GURNEE

W-T
ENGINEERING, INC.
1000 N. WILSON AVE.
CHICAGO, ILLINOIS 60642
PH: (847) 955-5840
FAX: (847) 955-5840

SENTE & RUBEL
ARCHITECTS
1955 RAYMOND DRIVE, NORTHBROOK, ILLINOIS 60062
(847) 272-9500

GARAGE UNDERGROUND
PLUMBING PLAN

PROJECT NO.

98117

DATE 03-14-00

DRAWN CPS

APPROVED JAT

SHEET

P-2